


MARK	SYMBOLS	QUANTITY	DESCRIPTION	LAHPS	REMARKS
A	—	4	EXIT SIGNS		
B	☐	2	EMERGENCY LIGHT		
C	⦿	3	FIRE EXTINGUISHER		
D	⊕	34	NOV OUTLET		

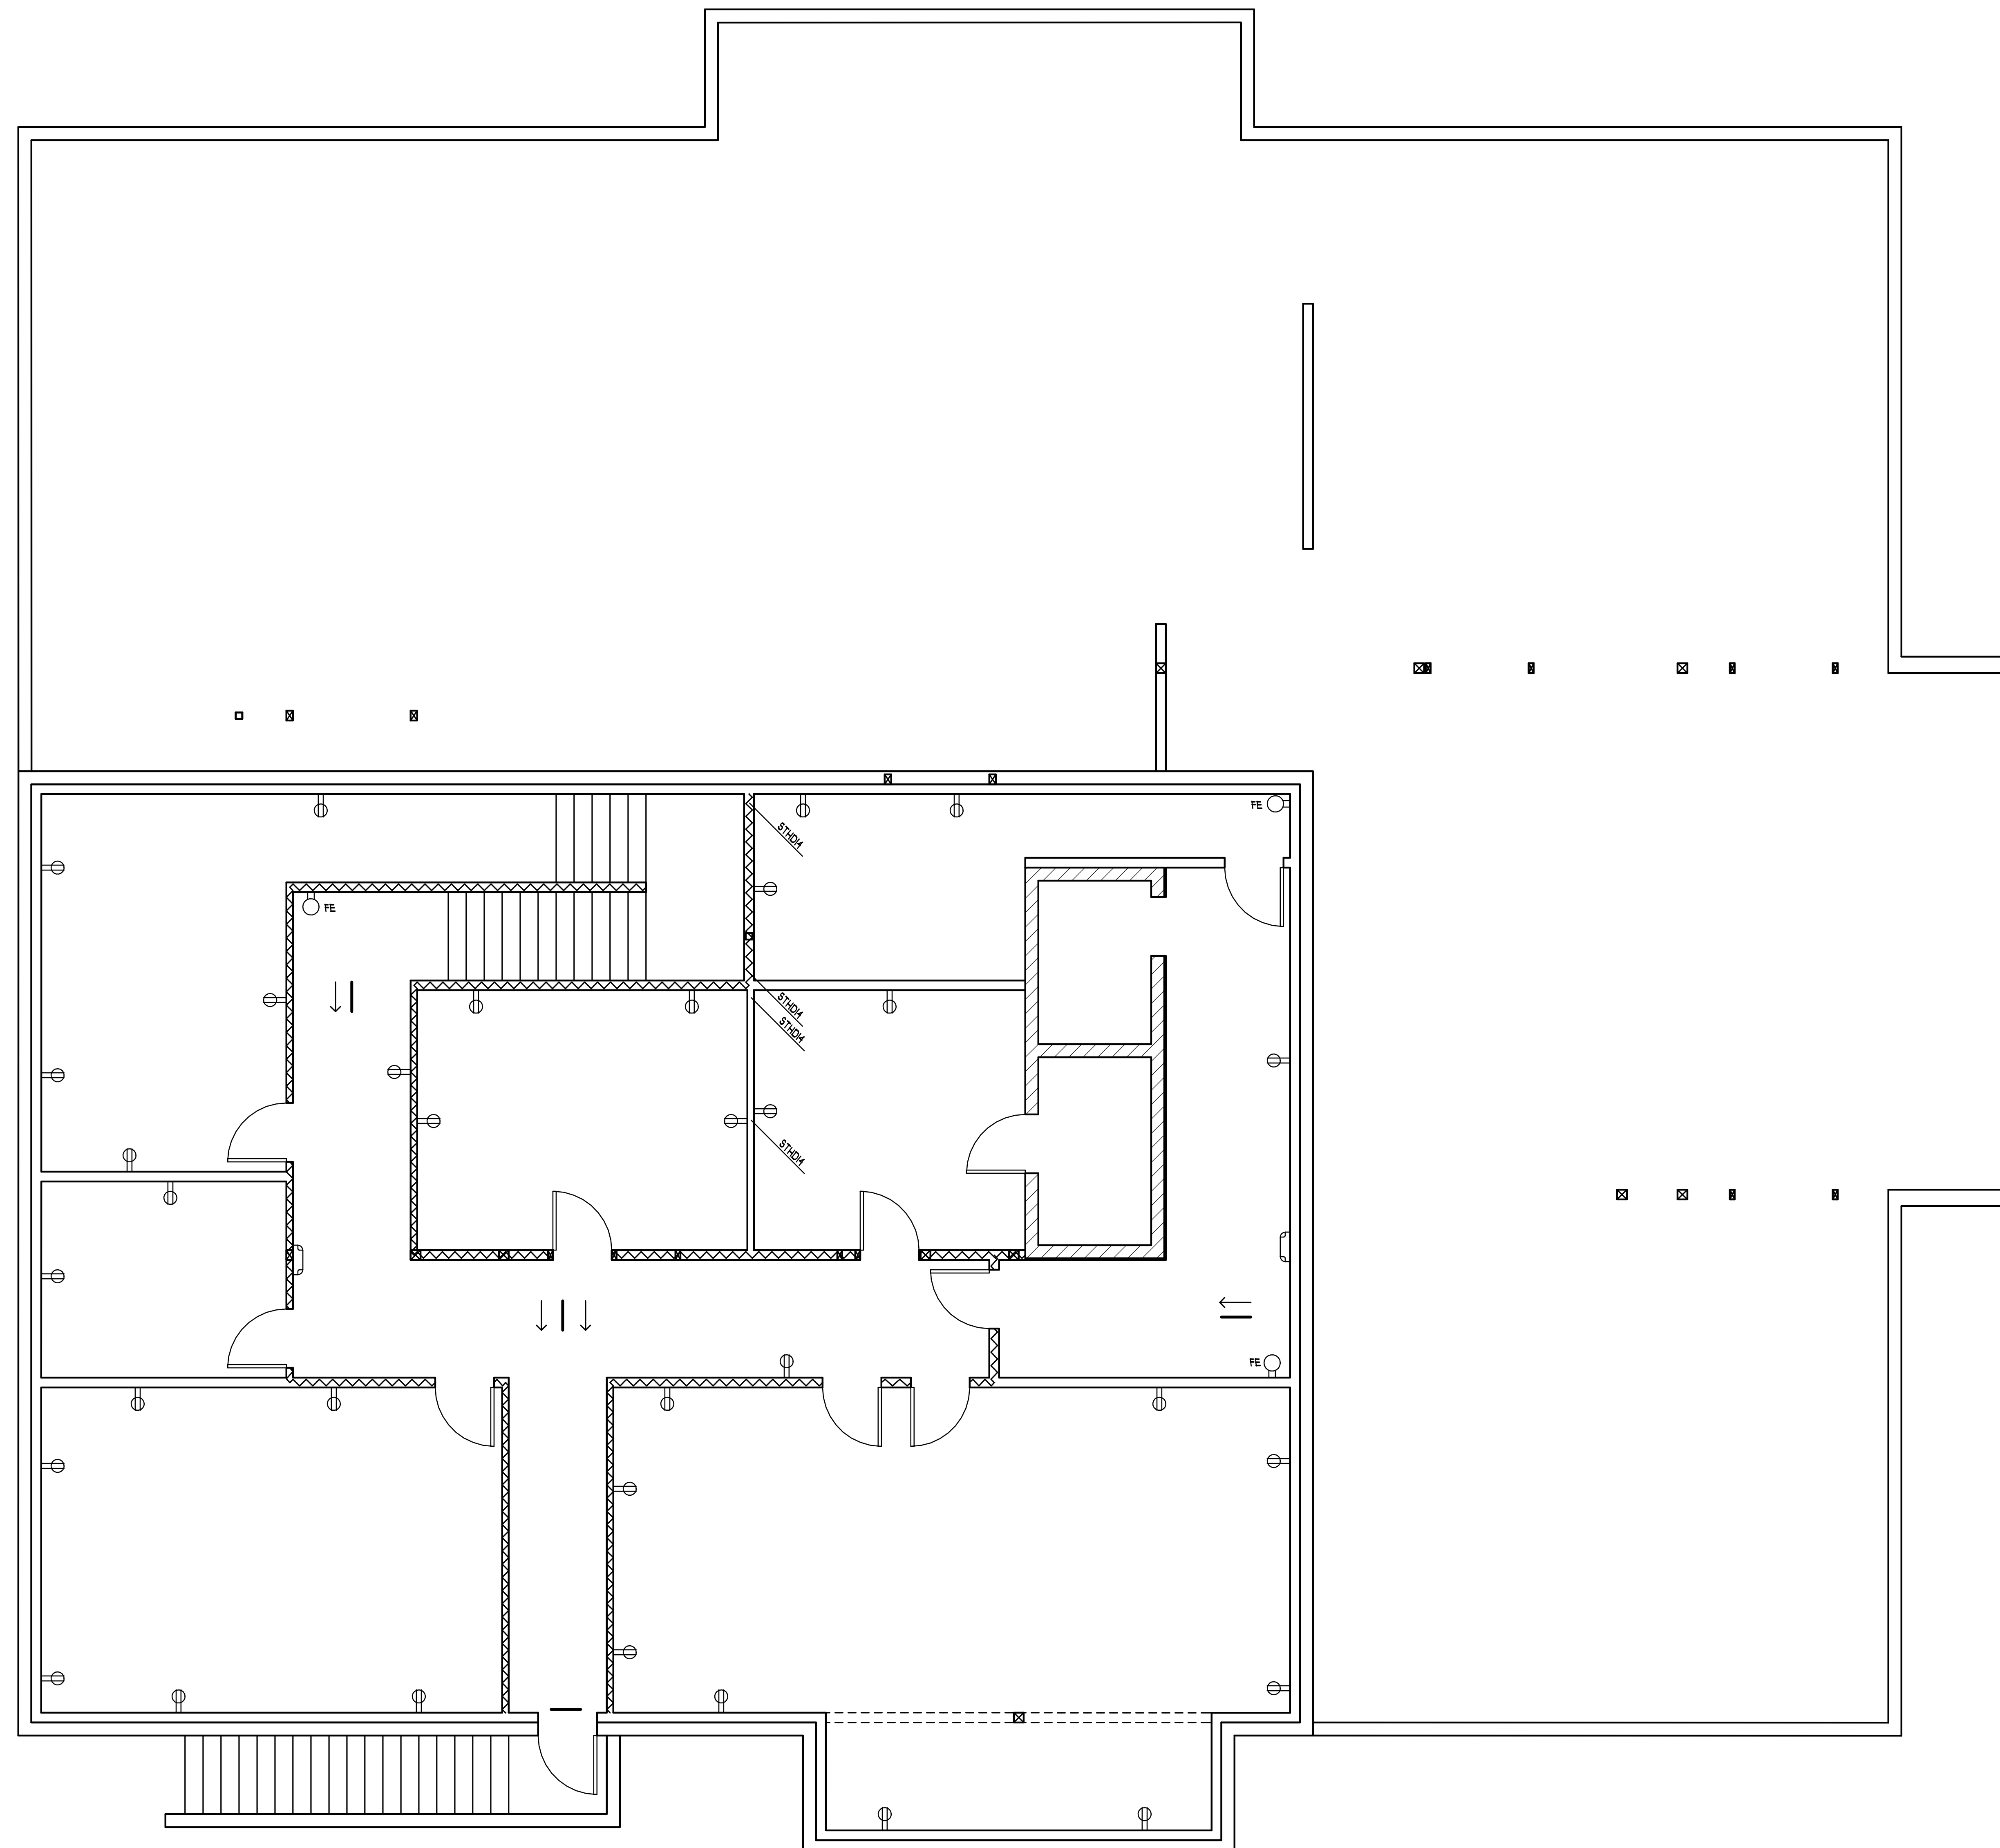


BASEMENT ELECTRICAL/SAFETY EQUIPMENT PLAN

SCALE: 1/4" = 1'-0"

DATE: 06/30/10	PLAN# P9-10068
REVISED	SHEET NUMBER
▲	17
▲	OF
▲	22
▲	
▲	

© COPYRIGHT 2007 PROFESSIONAL DESIGN, INC.

MARK	SYMBOLS	QUANTITY	DESCRIPTION	LAMPS	REMARKS
A		21	FLUORESCENT CEILING GRID	131-32W	14 WATTS TOTAL
B		1	FLUORESCENT CEILING GRID	121-32W	14 WATTS TOTAL
C					
D					

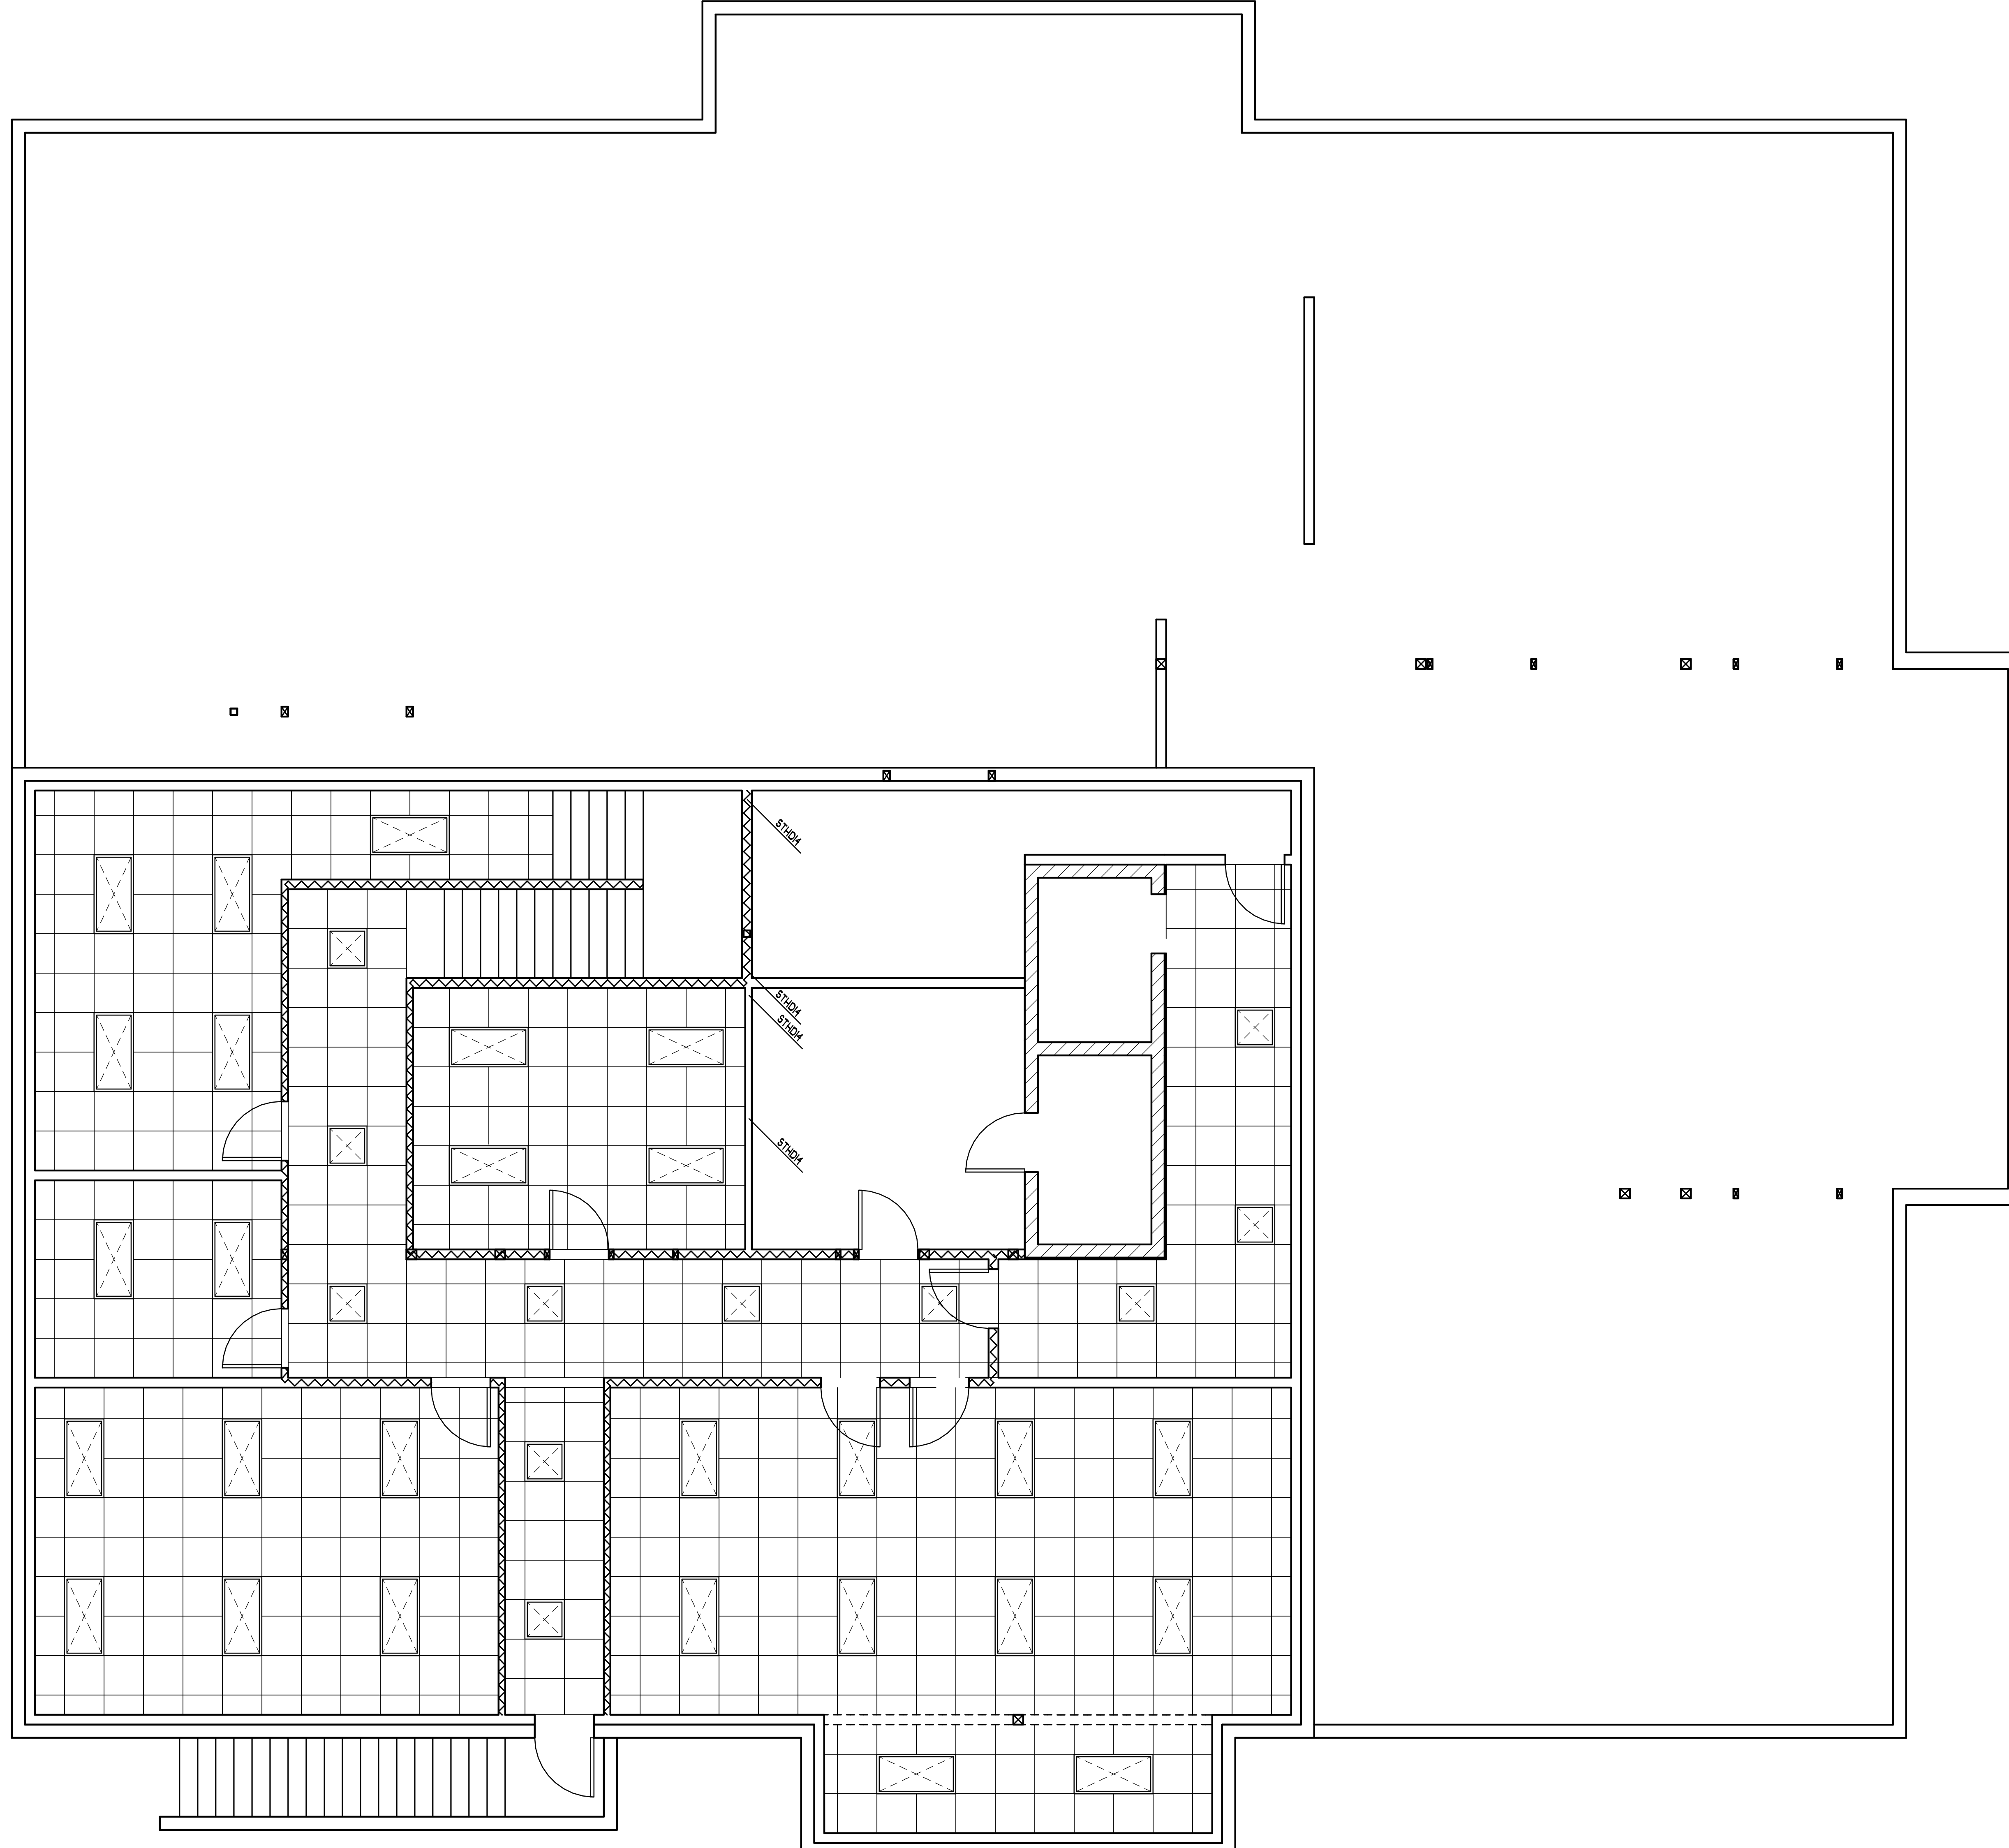


DATE: 06/30/10	PLAN# P9-10068
REVISED	SHEET NUMBER
	18 / OF 22

BASEMENT REFLECTED CEILING PLAN
SCALE: 1/4" = 1'-0"

© COPYRIGHT 2007 PROFESSIONAL DESIGN, INC.

MARK	SYMBOLS	QUANTITY	DESCRIPTION	LAMPS	REMARKS
A	—	13	EXIT SIGNS		
B	☐	8	EMERGENCY LIGHT		
C	⊙	4	FIRE EXTINGUISHER		
D	■	4	EXHAUST FAN		
E	⊕	101	BOY OUTLET		
F	⊕	1	4 PLEX BOY OUTLET		

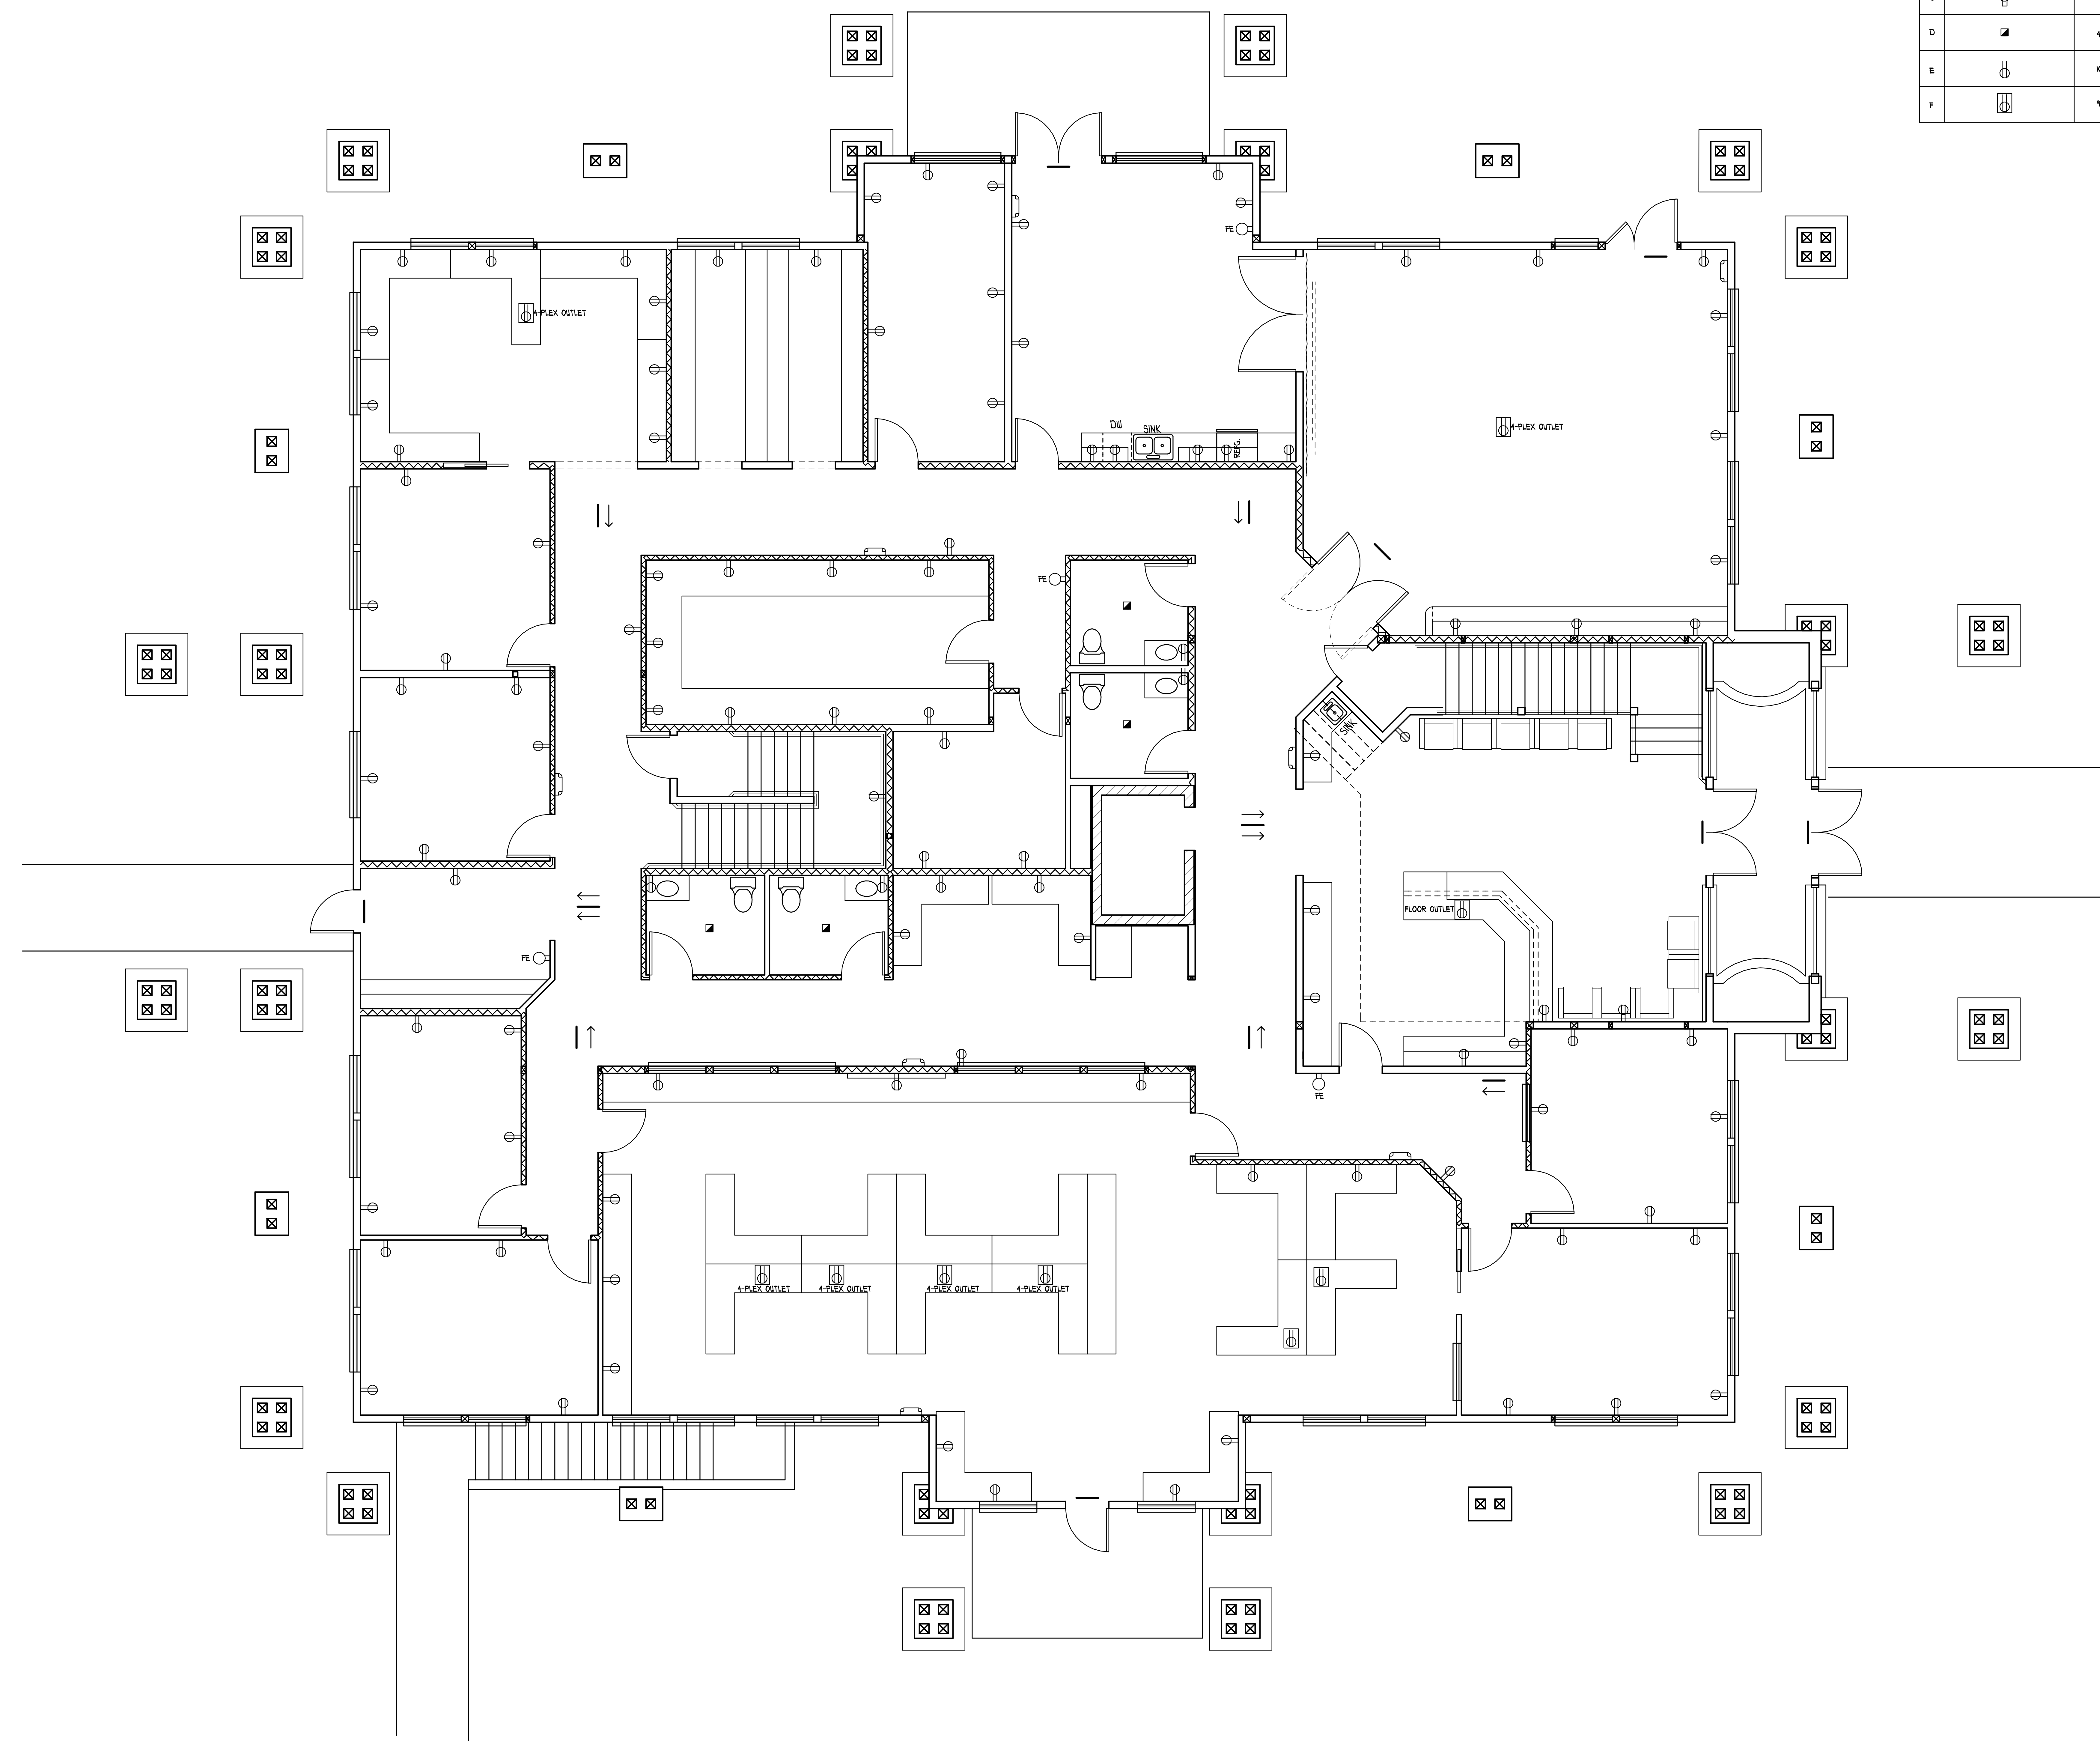


MAIN FLOOR ELECTRICAL/SAFETY EQUIPMENT PLAN
SCALE: 1/4" = 1'-0"

DATE: 06/30/10	PLAN# P9-10068
REVISED	SHEET NUMBER
▲	19
▲	OF
▲	22
▲	
▲	

© COPYRIGHT 2007 PROFESSIONAL RECORDS, INC.

MARK	SYMBOLS	QUANTITY	DESCRIPTION	LAMPS	REMARKS
A		41	FLUORESCENT CEILING GRID	(3)-320	14 BATTIS TOTAL
B		28	FLUORESCENT CEILING GRID	(2)-320	44 BATTIS TOTAL
C		2	SCOTTSDALE BALL MOUNT		
D		8	RECESSED CAN		
E					
F					

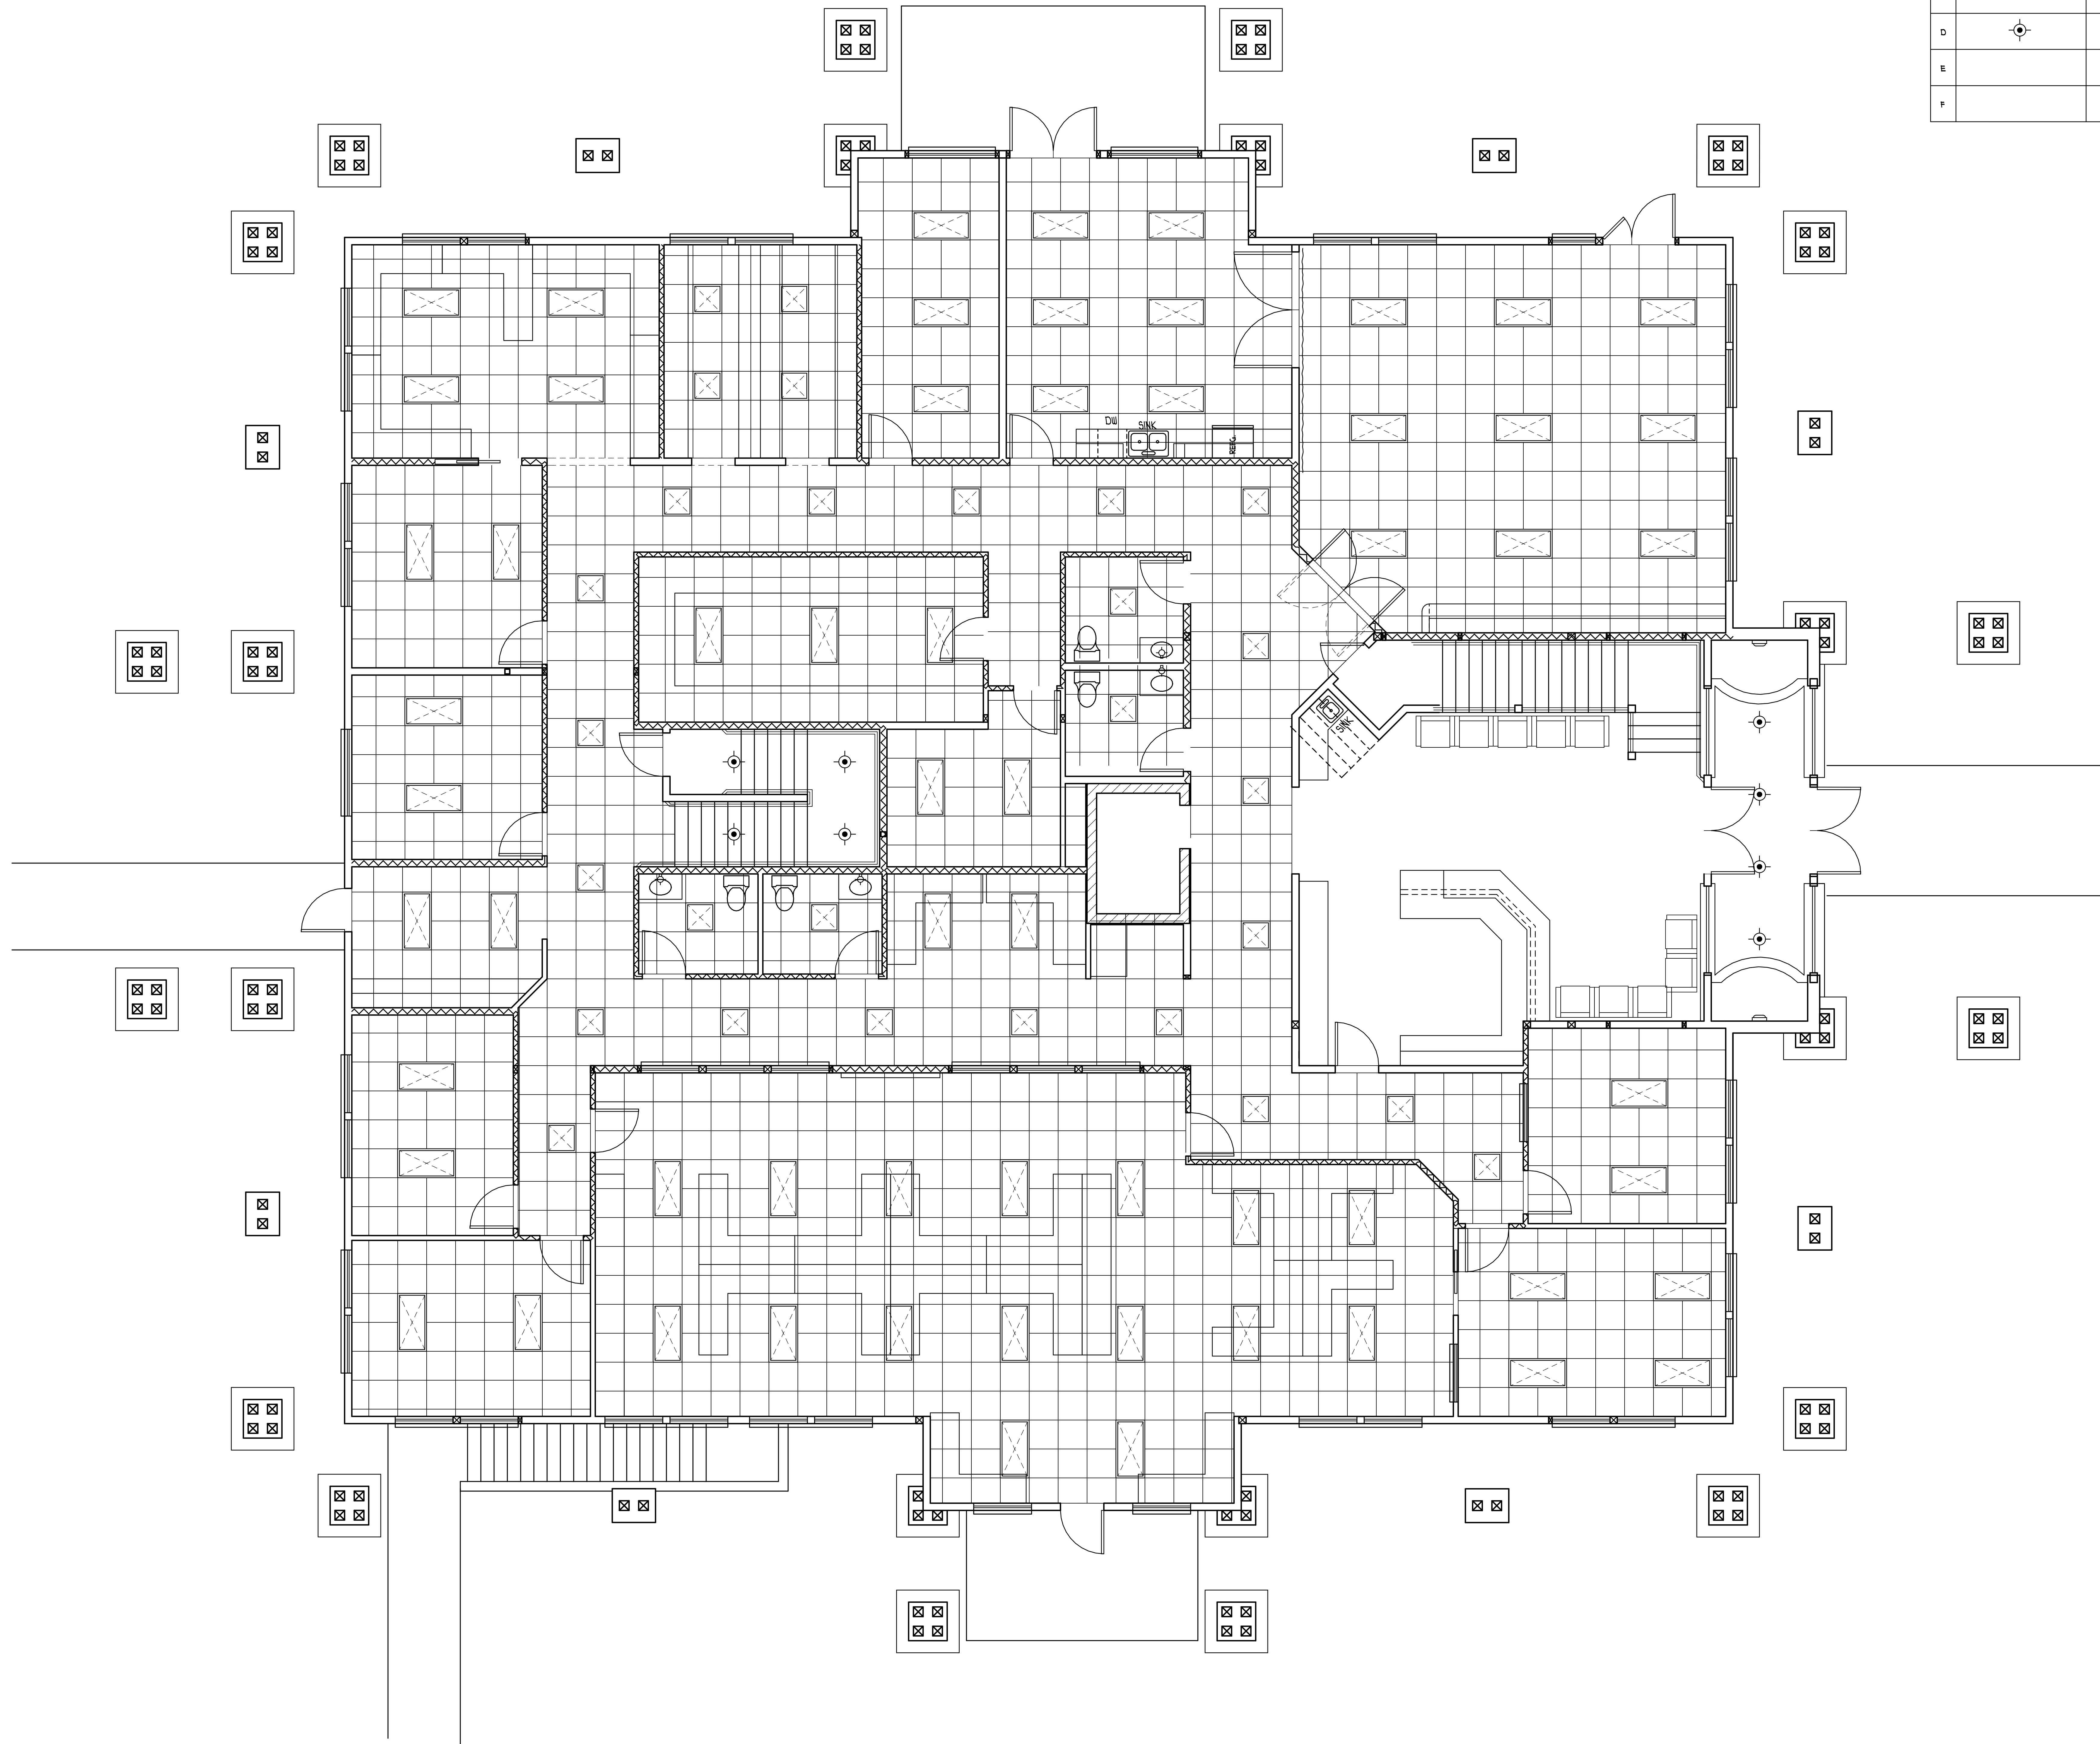


DATE: 06/30/10	PLAN# P9-10068
REVISED	SHEET NUMBER
	20 / OF 22

MAIN FLOOR REFLECTED CEILING PLAN

SCALE: 1/4" = 1'-0"


MARK	SYMBOLS	QUANTITY	DESCRIPTION	LAMPS	REMARKS
A	—	4	EXIT SIGNS		
B	☐	1	EMERGENCY LIGHT		
C	⦿	3	FIRE EXTINGUISHER		
D	■	4	EXHAUST FAN		
E	⊕	10	BOV OUTLET		
F					

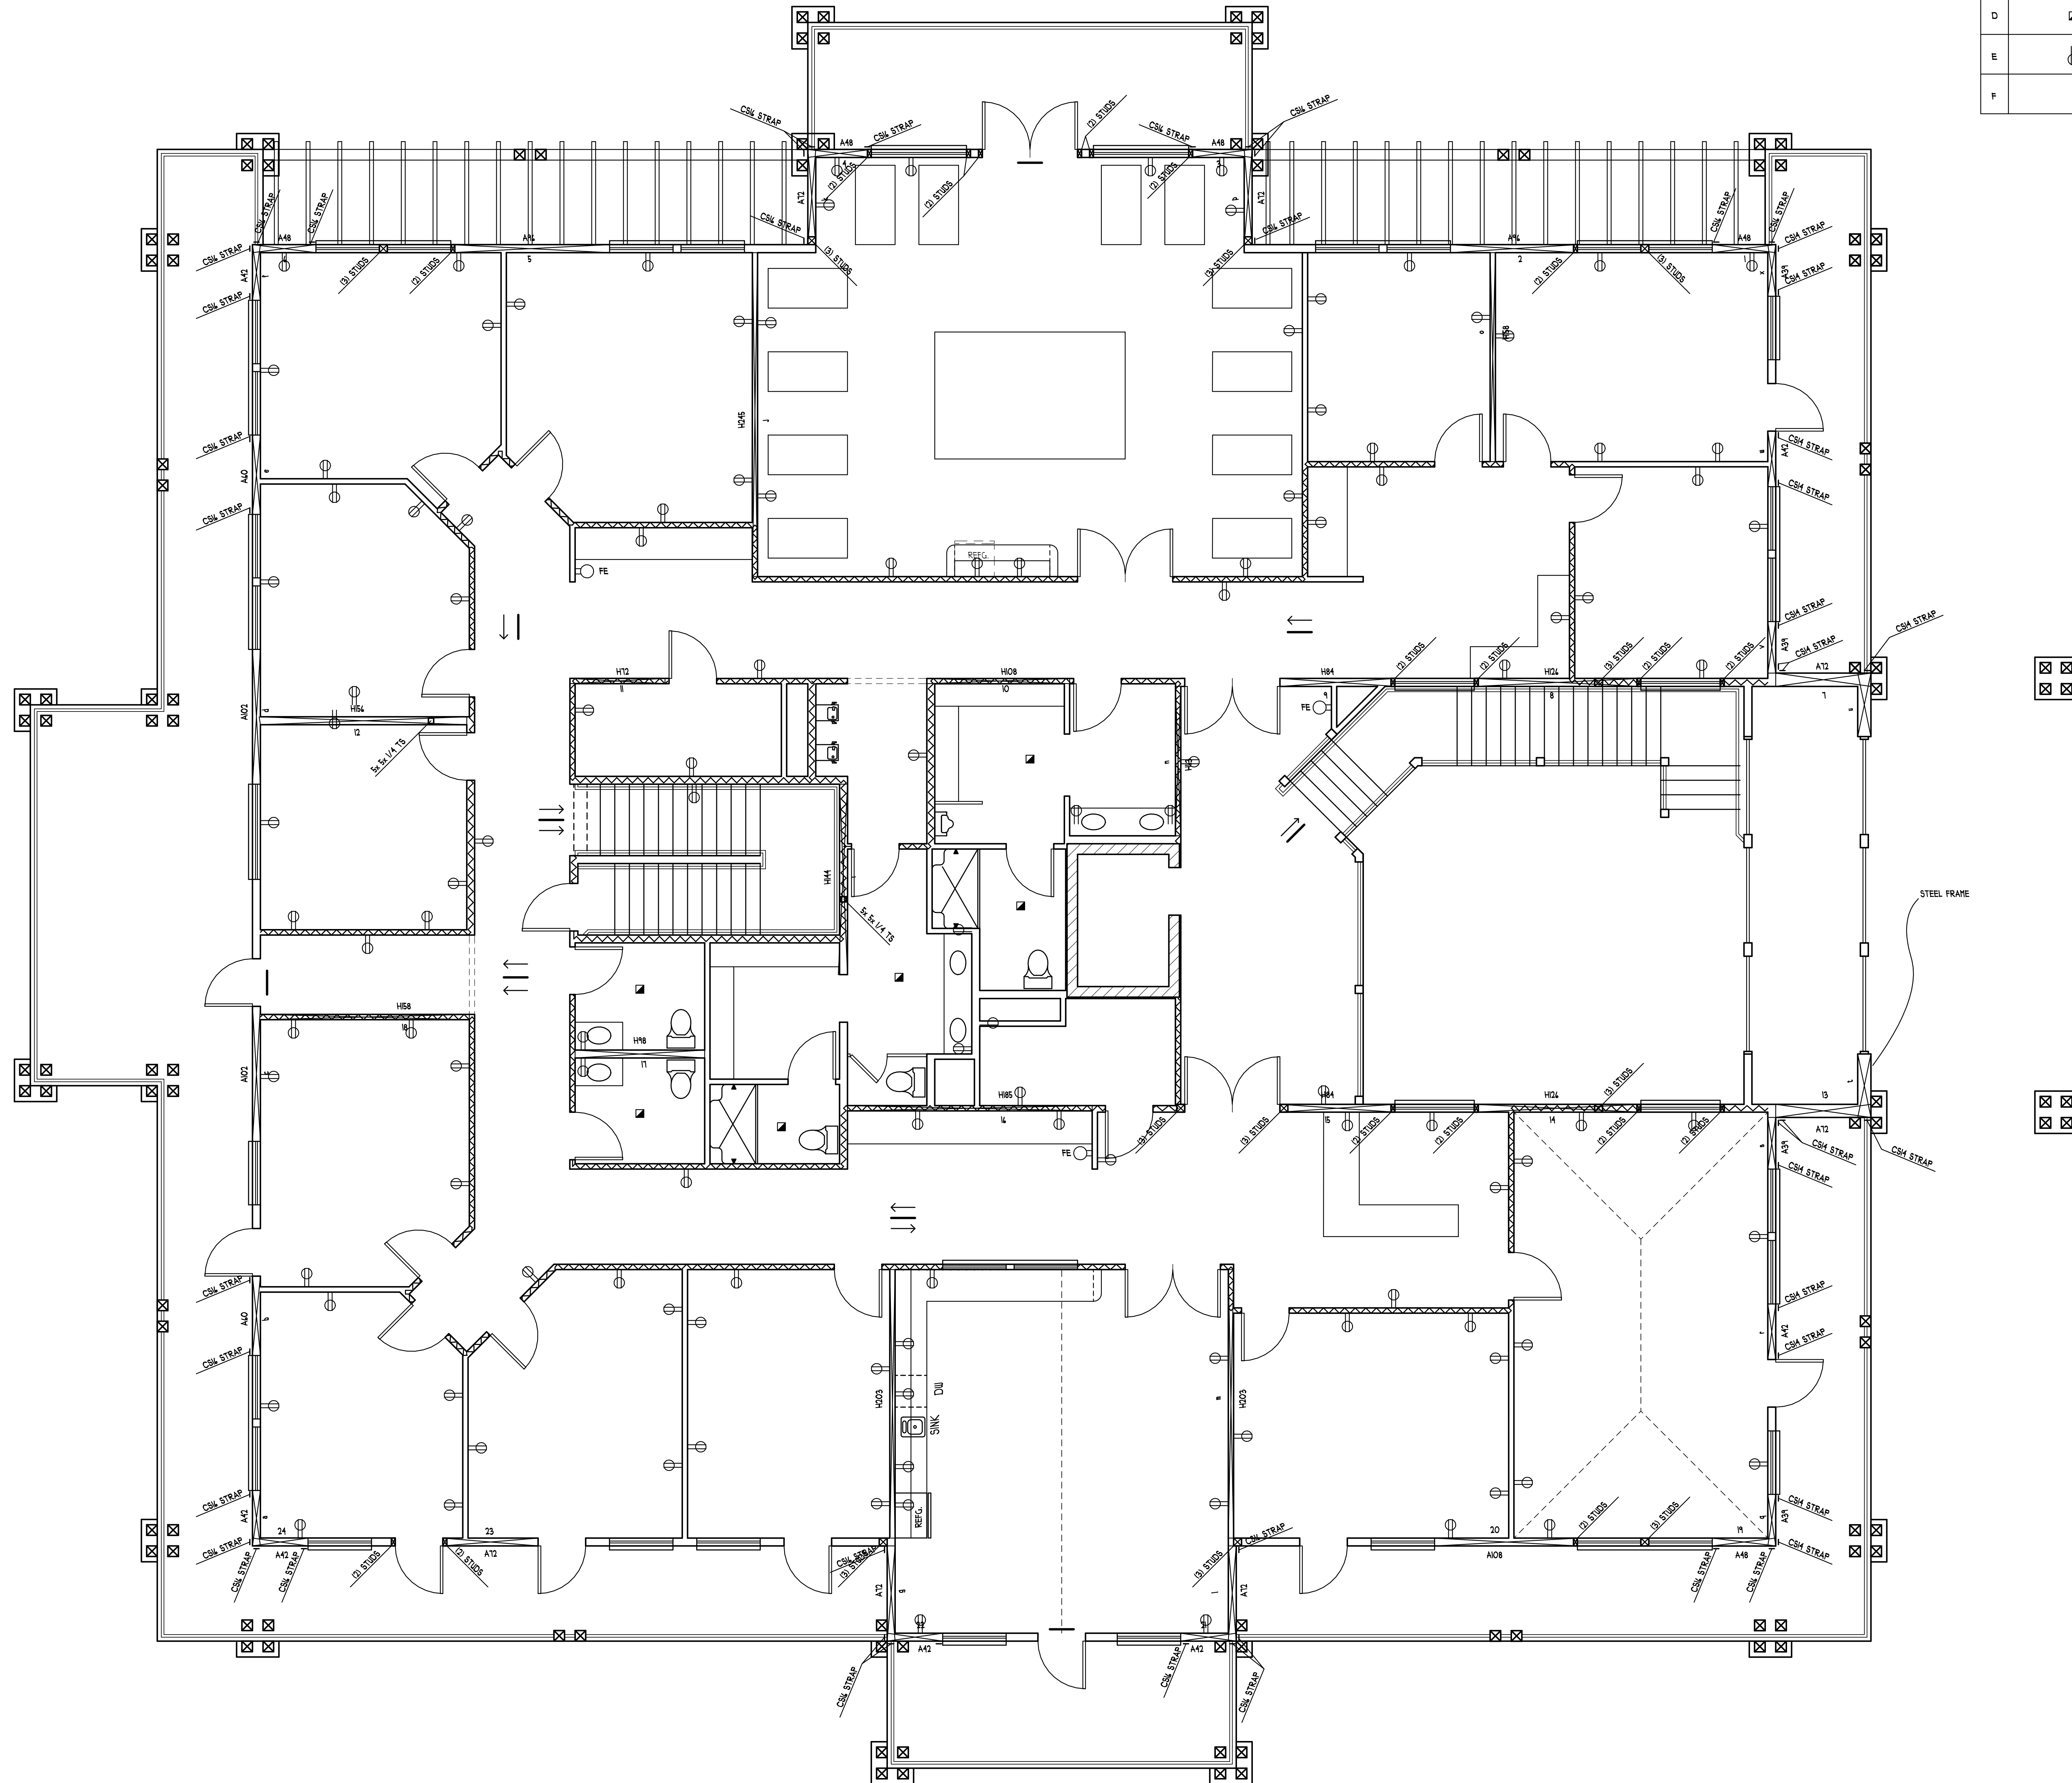

PANES a THRU x UP ↓ DOWN
 PANELS 1 THRU 24 LEFT - RIGHT
 A48 A - NAILING SEE SCHEDULE SHEET S1.0
 48 LENGTH OF PANEL IN INCHES
 (- -) ARE LOCATIONS OF REQUIRED STRAPS

DATE: 06/30/10	PLAN# P9-10068
REVISED	SHEET NUMBER
▲	21 / OF 22
▲	
▲	
▲	
▲	

SECOND FLOOR ELECTRICAL/SAFETY EQUIPMENT PLAN
 SCALE: 1/4" = 1'-0"

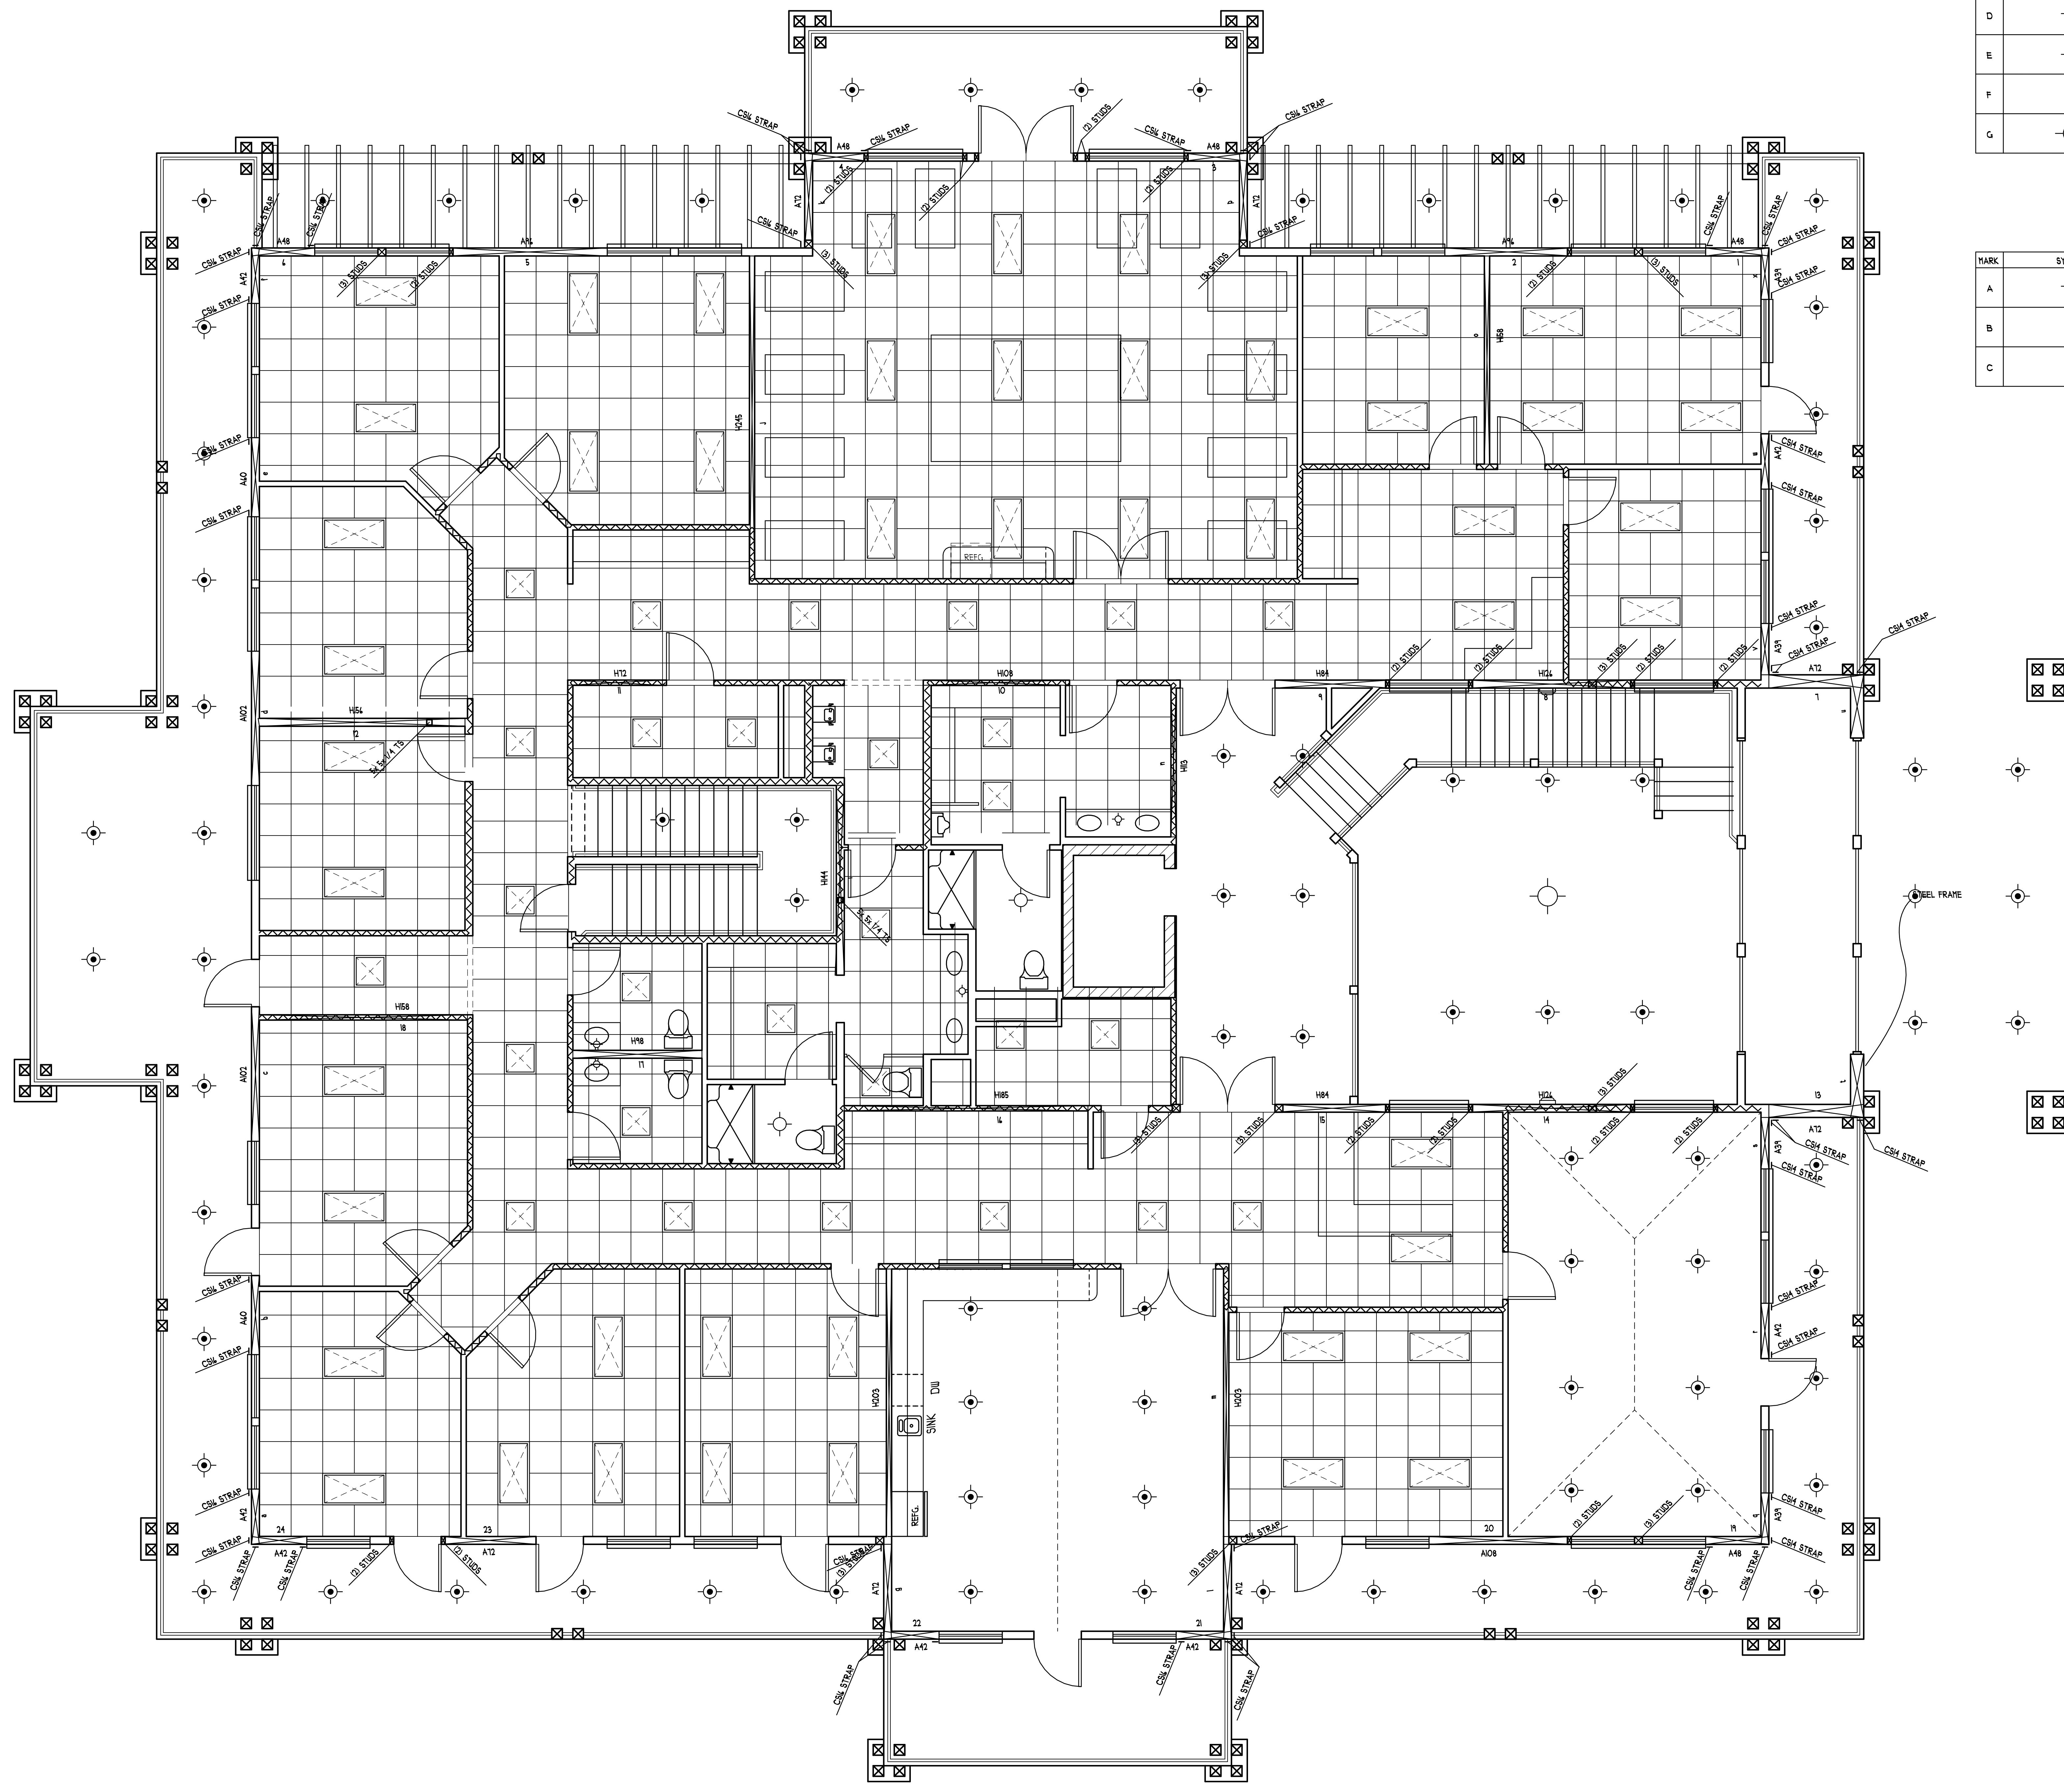

INTERIOR LIGHTING					
MARK	SYMBOLS	QUANTITY	DESCRIPTION	LAMPS	REMARKS
A		48	FLUORESCENT CEILING GRID	131-328	48 WATTS TOTAL
B		24	FLUORESCENT CEILING GRID	121-328	48 WATTS TOTAL
C		2	SCOTTSDALE	11-100B	100 WATTS TOTAL
D		31	RECESSED CAN		
E		2	INCANDESCENT		
F		4	INCANDESCENT		
G		1	CUSTOM CHANDELLIER		

EXTERIOR LIGHTING					
MARK	SYMBOLS	QUANTITY	DESCRIPTION	LAMPS	REMARKS
A		52	RECESSED CAN	11-100B	WEATHERPROOF
B					
C					

PANES a THRU x UP t DOWN
 PANELS 1 THRU 24 LEFT - RIGHT
 A48 A - NAILING SEE SCHEDULE SHEET S1.0
 48 LENGTH OF PANEL IN INCHES
 (- -) ARE LOCATIONS OF REQUIRED STRAPS

DATE: 06/30/10	PLAN# P9-10068
REVISED	SHEET NUMBER
	22
	OF
	22

SECOND FLOOR REFLECTED CEILING PLAN
 SCALE: 1/4" = 1'-0"

© COPYRIGHT 2007 PROFESSIONAL RECORDS, INC.